


PROPOSED ONE STORY ADDITION

108 PARK AVENUE, MILLER PLACE, NY, 11764, 631-793-2422

Copyright of Architectural Drawings- These plans are protected by federal law and are subject to copyright protection as an "architectural work" under section 102 of the copyright act, 17 U.S.A. as amended December 1990 and known as Architectural Works Copyright Protection Act of 1990. These drawings are provided as an instrument for construction for the construction project at the address shown on the title block of the drawings and they may not be used for any project other than that listed at the address shown on the title block without the written consent and compensation of the architect. This protection includes but is not limited to the overall form as well as the arrangement and composition of spaces and elements of the designs. Under such protection, unauthorized use of these plans, work or home represented, can legally result in the cessation of construction or buildings being seized and/or monetary compensation to Edward Koenig.

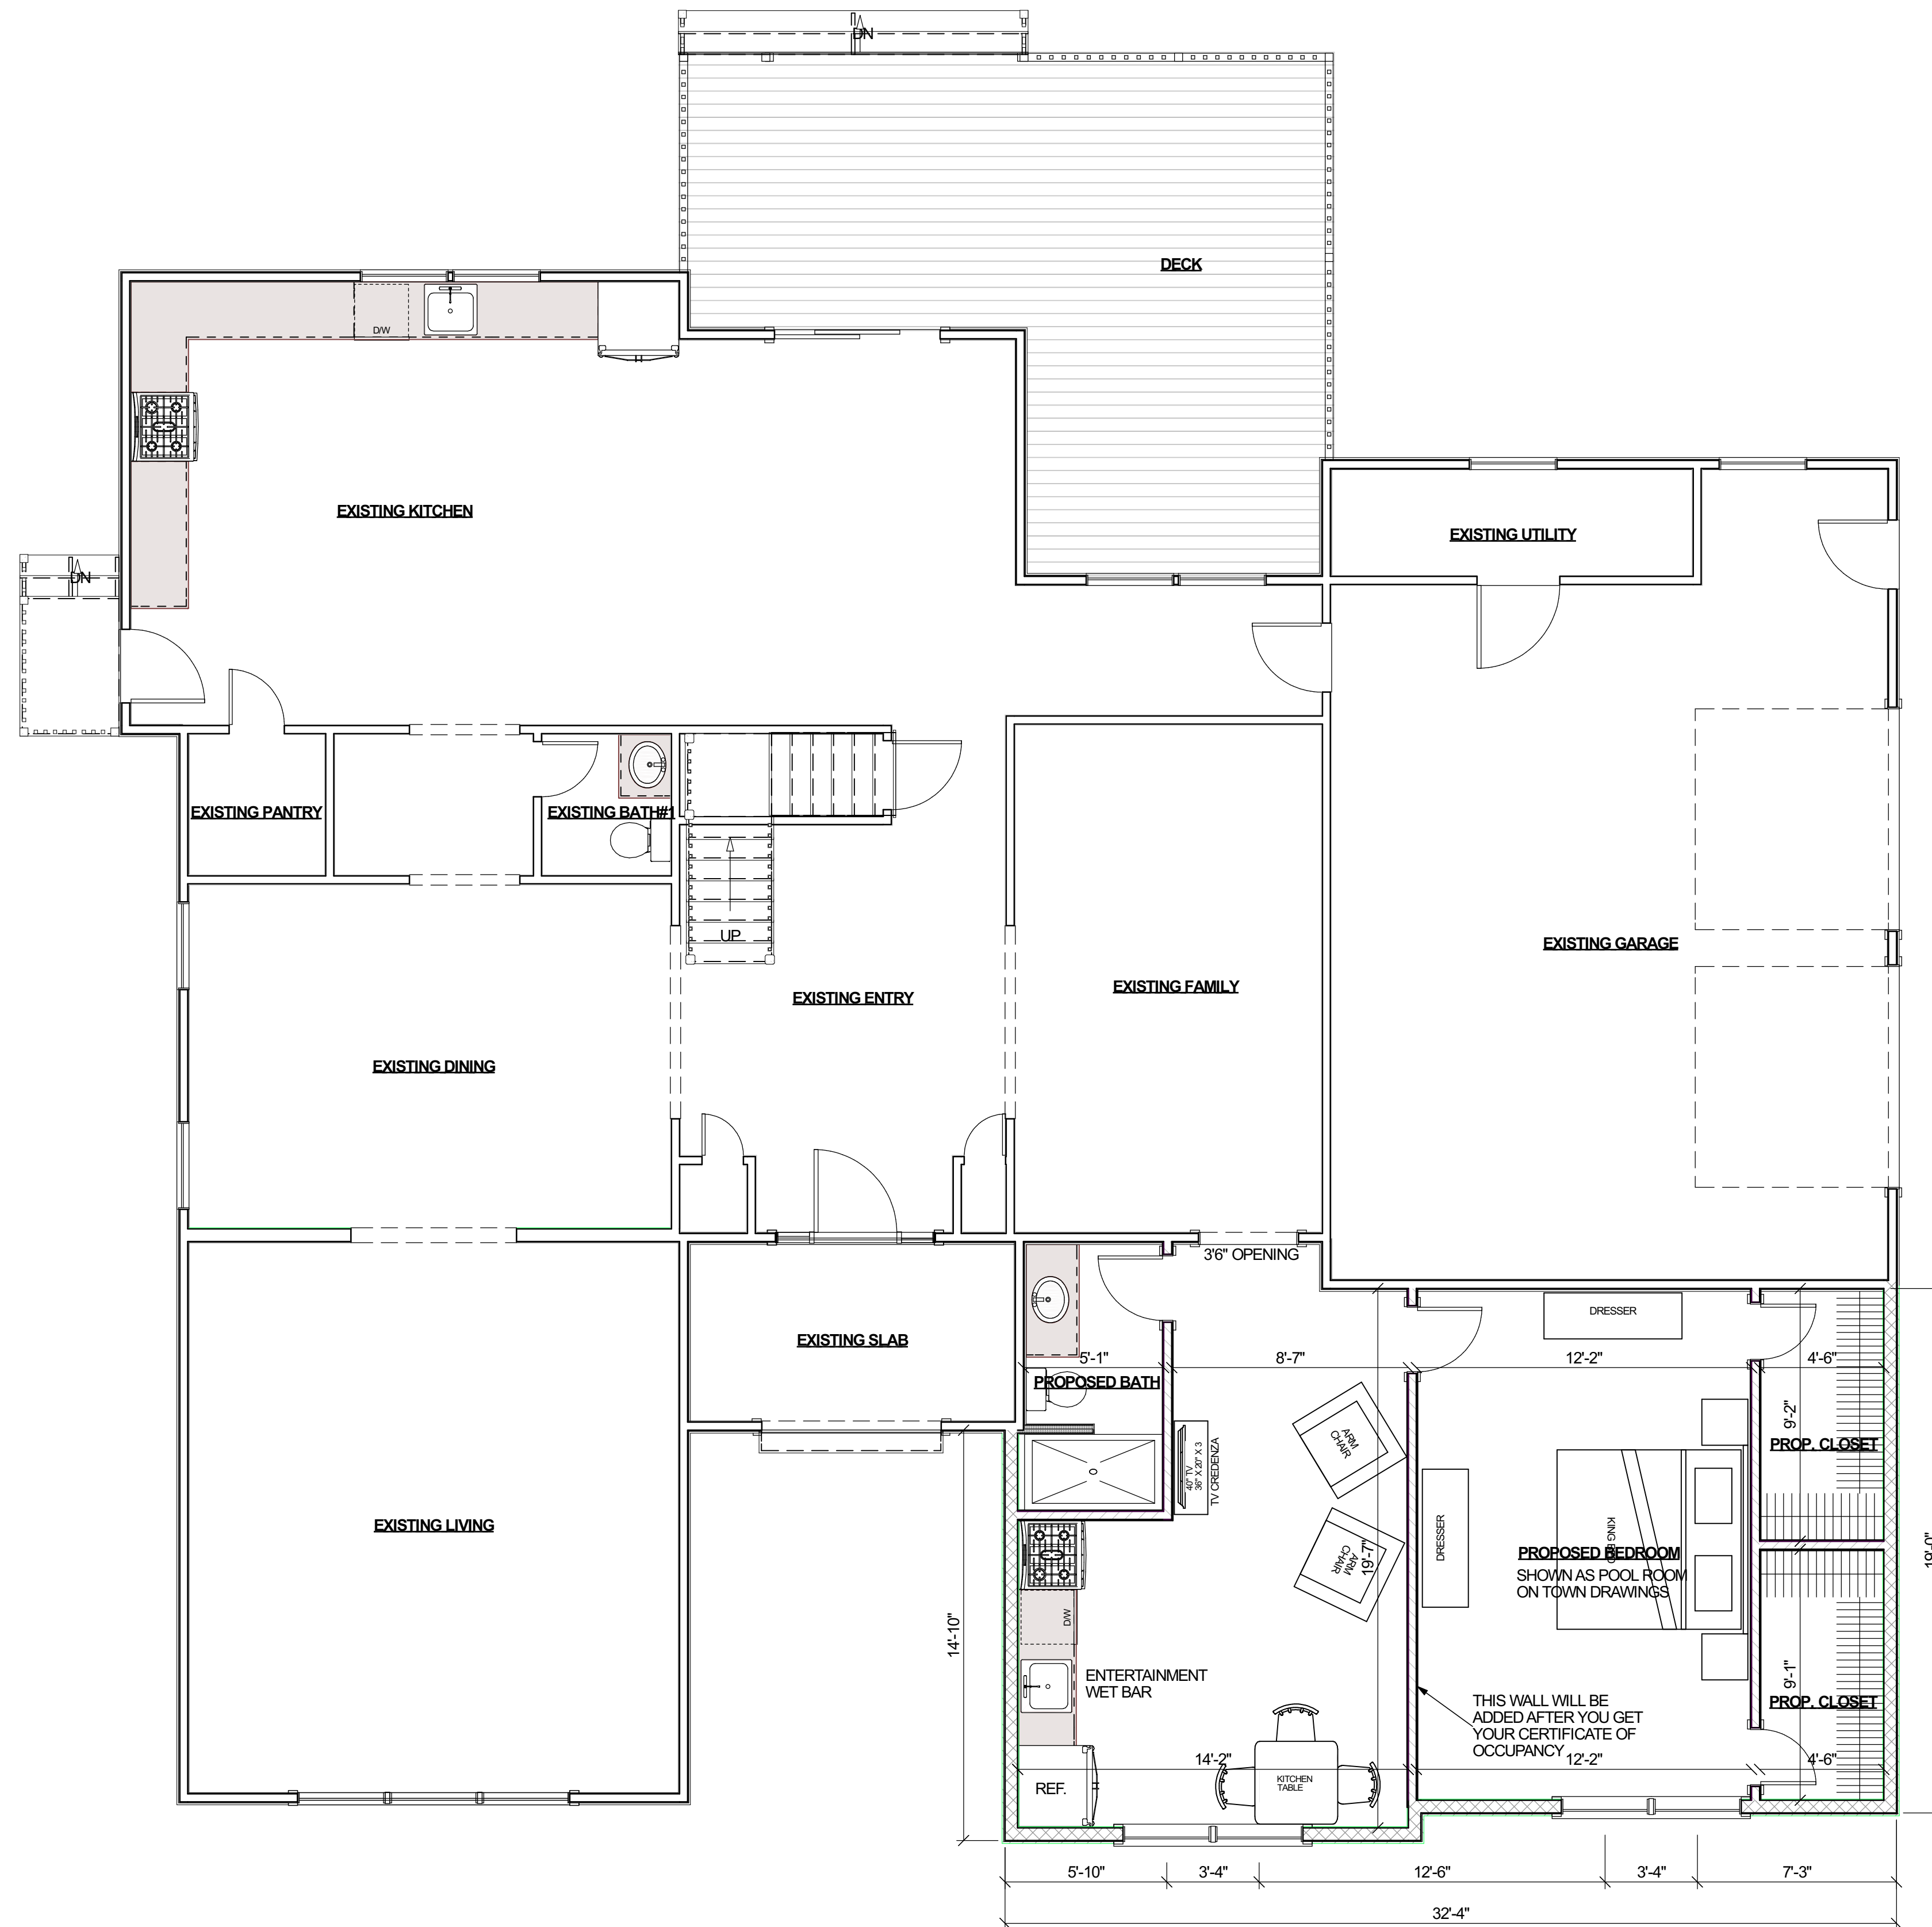

FIRST FLOOR DESIGN PLAN
SCALE: 1/4" = 1'-0"

SHEET INDEX


NO.	TITLE
A-1	DESIGN FLOOR PLANS
A-2	DESIGN ELEVATIONS
A-3	RENDERINGS
A-4	
A-5	CODE SHEET
A-6	SPECIFICATIONS
A-7	LEGENDS & PLUMBING RISER DIAGRAMS
A-8	THERMAL PLANS
A-9	DEMOLITION PLANS
A-10	DEMOLITION PLANS
A-11	DEMOLITION PLANS
A-12	FOUNDATION PLAN
A-13	FIRST FLOOR CONSTRUCTION PLAN
A-14	SECOND FLOOR CONSTRUCTION PLAN
A-15	ROOF PLAN
A-16	ELECTRICAL PLANS
A-17	ELECTRICAL PLANS
A-18	ELECTRICAL PLANS
A-19	ELEVATIONS
A-20	ELEVATIONS
A-21	SECTIONS
A-22	SECTIONS
A-23	SCHEDULES
A-24	DETAILS
A-25	DETAILS
A-26	DETAILS
A-27	DETAILS
A-28	DETAILS

NO.	DESCRIPTION	DATE
1	ISSUED FOR DESIGN APPROVAL	XXXX

CAD File Name: STURGES DESIGN 1.layout

Architect's Seal

EDWARD KOENIG ARCHITECT

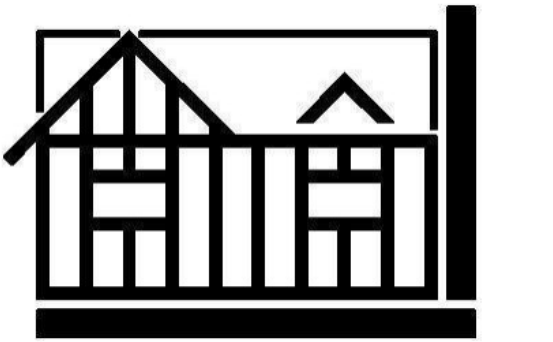

www.EDWARDKOENIG.COM

Architecture Firm:
EDWARD KOENIG - ARCHITECT
PO BOX 1051
150 VETERANS MEMORIAL HWY.
COMMACK, NY 11725
631-948-7030 (cell & text)
Website: www.EDWARDKOENIG.com
Email: EDKOENIG49@gmail.com

Project Title:
PROPOSED ONE STORY ADDITION
ROBERT STURGES
108 PARK AVENUE
MILLER PLACE, NY 11764
631-793-2422
RSTURGES@FINANCIALGUIDE.COM
DISTRICT 200 - SECTION 120 - BLOCK 2 - LOT 9

DESIGN FLOOR PLANS

Drawing No.
A-1

PROPOSED ONE STORY ADDITION

108 PARK AVENUE, MILLER PLACE, NY, 11764, 631-793-2422

Copyright of Architectural Drawings- These plans are protected by federal law and are subject to copyright protection as an "architectural work" under section 102 of the copyright act, 17 U.S.A. as amended December 1990 and known as Architectural Works Copyright Protection Act of 1990. These drawings are provided as an instrument for construction for the construction project at the address shown on the title block of the drawings and they may not be used for any project other than that listed at the address shown on the title block without the written consent and compensation of the architect. This protection includes but is not limited to the overall form as well as the arrangement and composition of spaces and elements of the designs. Under such protection, unauthorized use of these plans, work or home represented, can legally result in the cessation of construction or buildings being seized and/or monetary compensation to Edward Koenig.



FRONT DESIGN ELEVATION
SCALE: 1/4" = 1'-0"



RIGHT DESIGN ELEVATION
SCALE: 1/4" = 1'-0"



SHEET INDEX		
NO.	TITLE	
A-1	DESIGN FLOOR PLANS	
A-2	DESIGN ELEVATIONS	
A-3	RENDERINGS	
A-4	CODE SHEET	
A-5	SPECIFICATIONS	
A-6	LEGENDS & PLUMBING RISER DIAGRAMS	
A-7	THERMAL PLANS	
A-8	DEMOLITION PLANS	
A-9	DEMOLITION PLANS	
A-10	DEMOLITION PLANS	
A-11	DEMOLITION PLANS	
A-12	FOUNDATION PLAN	
A-13	FIRST FLOOR CONSTRUCTION PLAN	
A-14	SECOND FLOOR CONSTRUCTION PLAN	
A-15	ROOF PLAN	
A-16	ELECTRICAL PLANS	
A-17	ELECTRICAL PLANS	
A-18	ELECTRICAL PLANS	
A-19	ELEVATIONS	
A-20	ELEVATIONS	
A-21	SECTIONS	
A-22	SECTIONS	
A-23	SCHEDULES	
A-24	DETAILS	
A-25	DETAILS	
A-26	DETAILS	
A-27	DETAILS	
A-28	DETAILS	
NO.	DESCRIPTION	DATE
1	ISSUED FOR DESIGN APPROVAL	XXXX

CAD File Name: STURGES DESIGN 1.layout

Architect's Seal

EDWARD KOENIG ARCHITECT

www.EDWARDKOENIG.COM

Architecture Firm:
EDWARD KOENIG - ARCHITECT
PO BOX 1051
150 VETERANS MEMORIAL HWY.
COMMACK, NY 11725
631-948-7030 (cell & text)
Website: www.EDWARDKOENIG.com
Email: EDKOENIG49@gmail.com

Project Title:
PROPOSED ONE STORY ADDITION
ROBERT STURGES
108 PARK AVENUE
MILLER PLACE, NY 11764
631-793-2422
RSTURGES@FINANCIALGUIDE.COM
DISTRICT 200 - SECTION 120 - BLOCK 2 - LOT 9

Sheet Title:
DESIGN ELEVATIONS

Drawing No.
A-2