
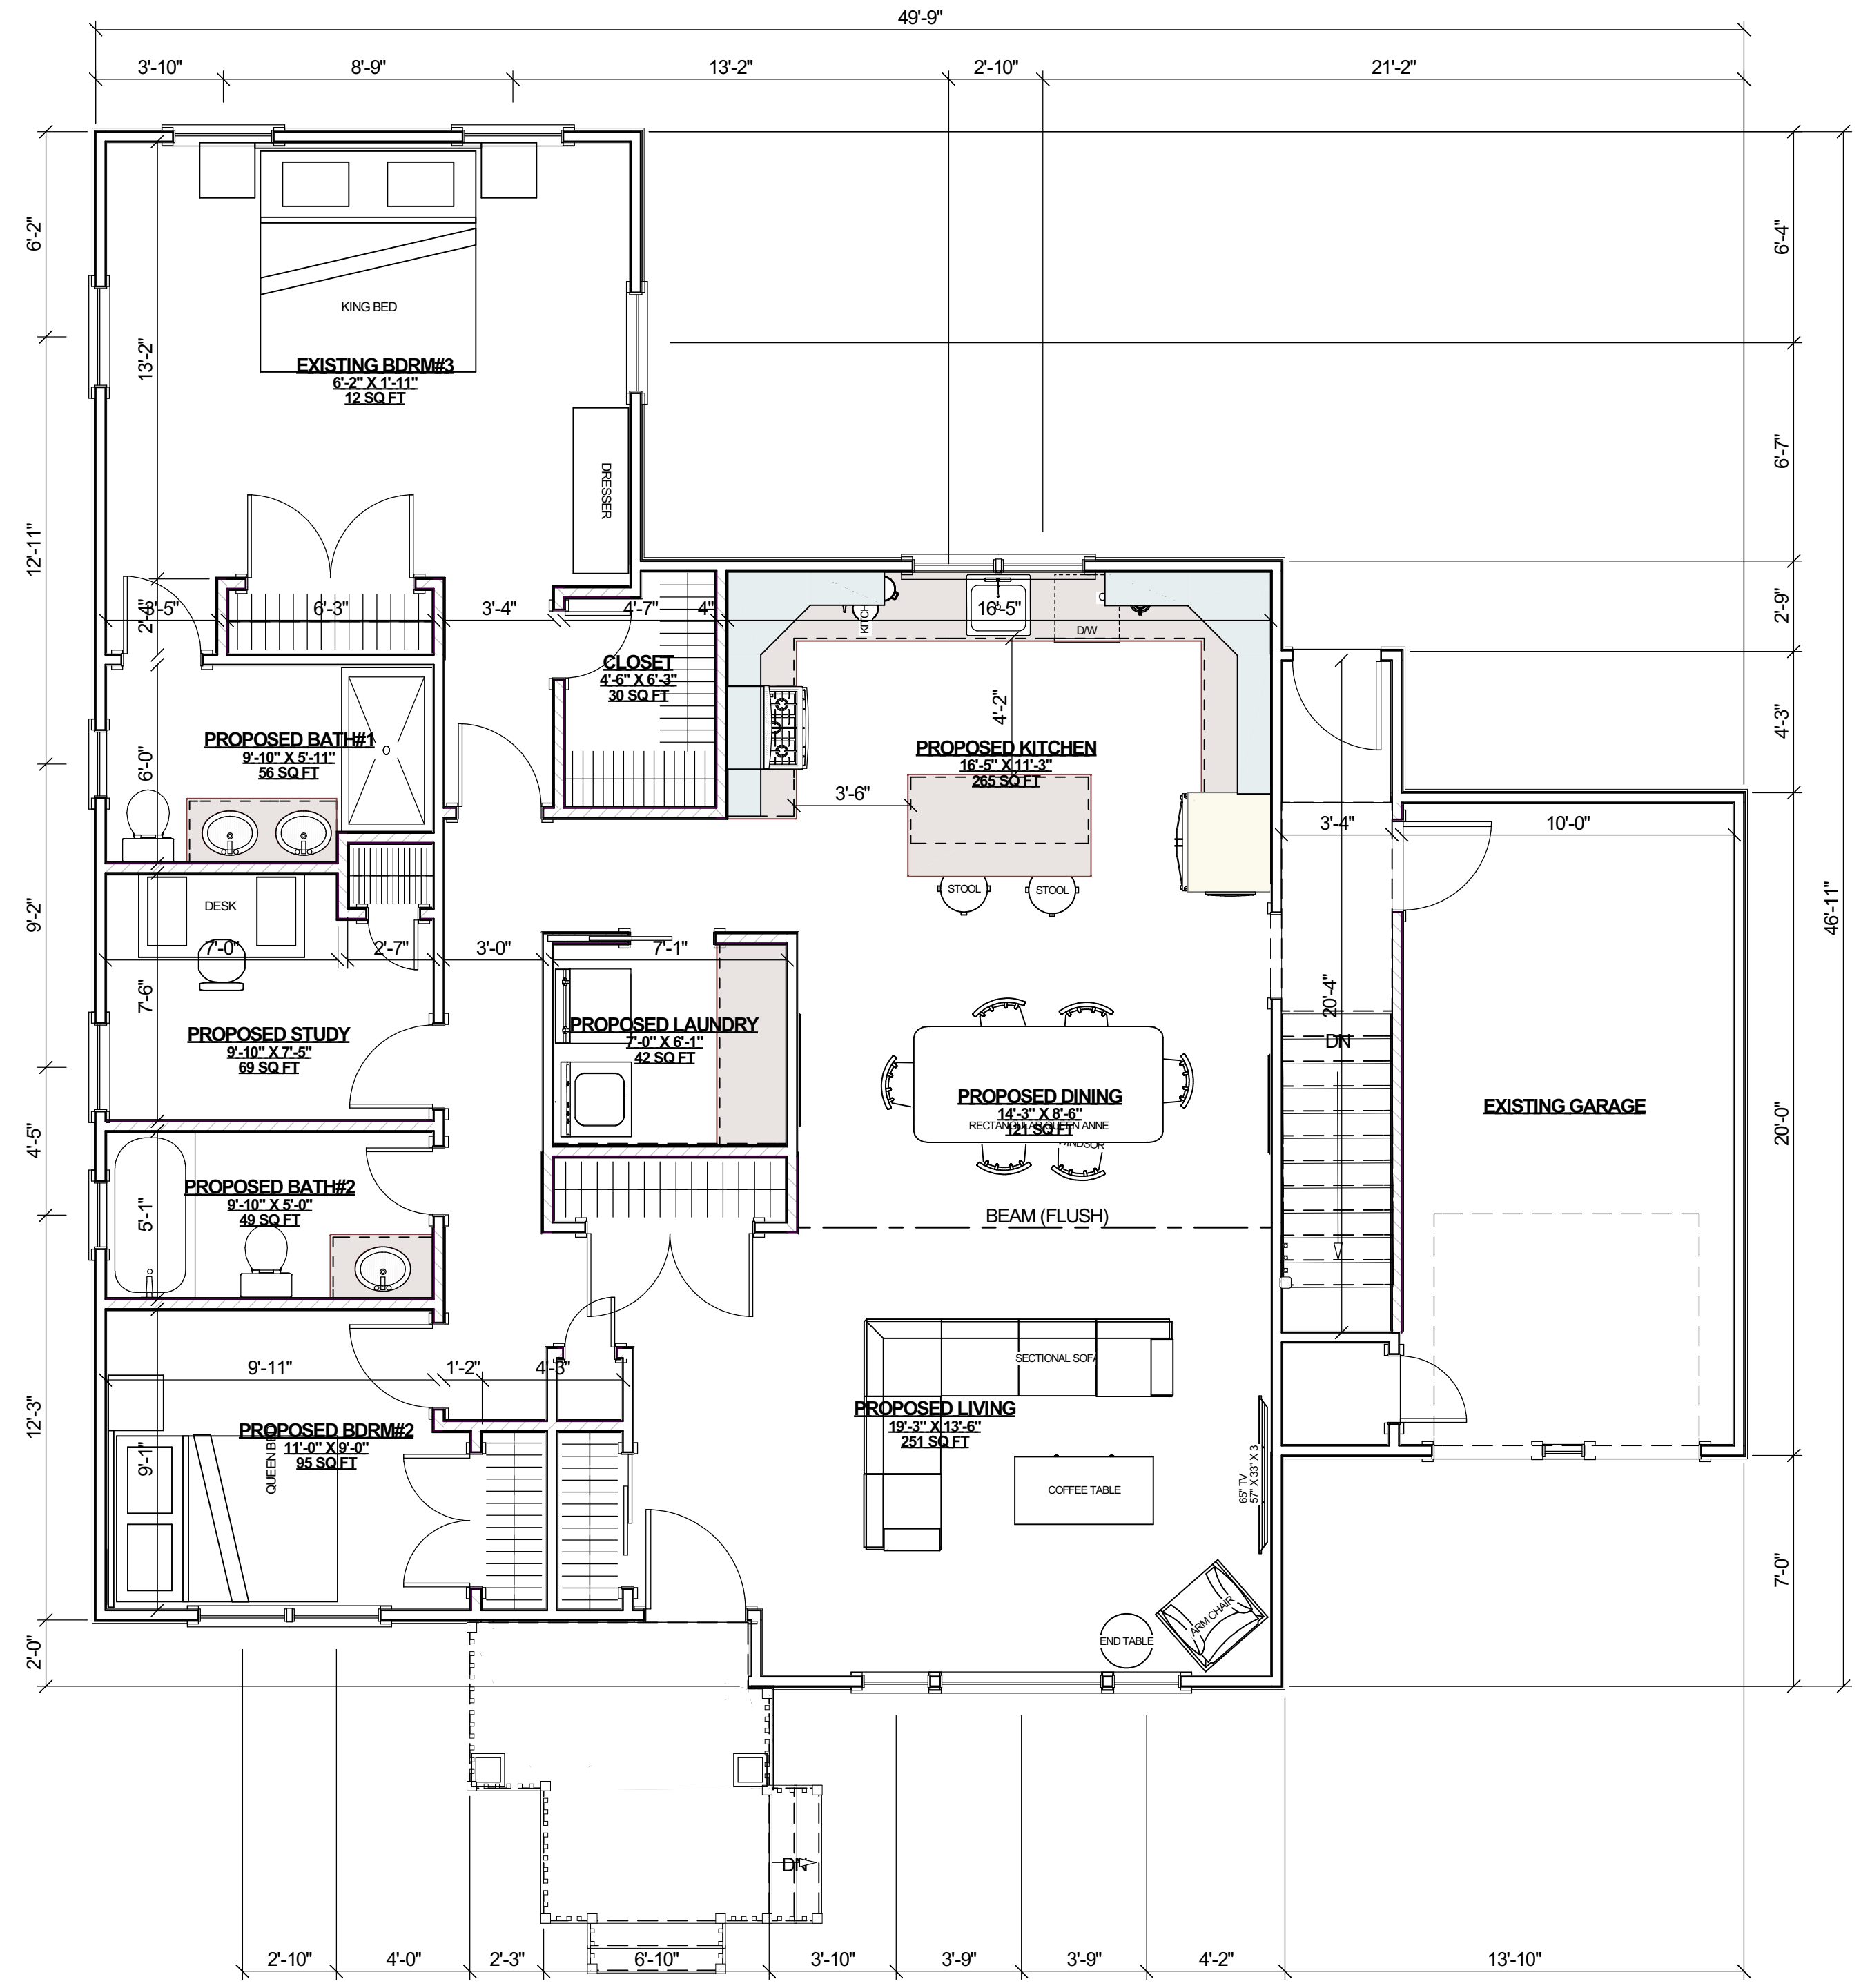


# ROOF RENOVATION

8 ELLINGTON DRIVE, EAST NORTH PORT, NY, 11731, 516-524-9298

Copyright of Architectural Drawings- These plans are protected by federal law and are subject to copyright protection as an "architectural work" under section 102 of the copyright act, 17 U.S.A. as amended December 1990 and known as Architectural Works Copyright Protection Act of 1990. These drawings are provided as an instrument for construction for the construction project at the address shown on the title block of the drawings and they may not be used for any project other than that listed at the address shown on the title block without the written consent and compensation of the architect. This protection includes but is not limited to the overall form as well as the arrangement and composition of spaces and elements of the designs. Under such protection, unauthorized use of these plans, work or home represented, can legally result in the cessation of construction or buildings being seized and/or monetary compensation to Edward Koenig.

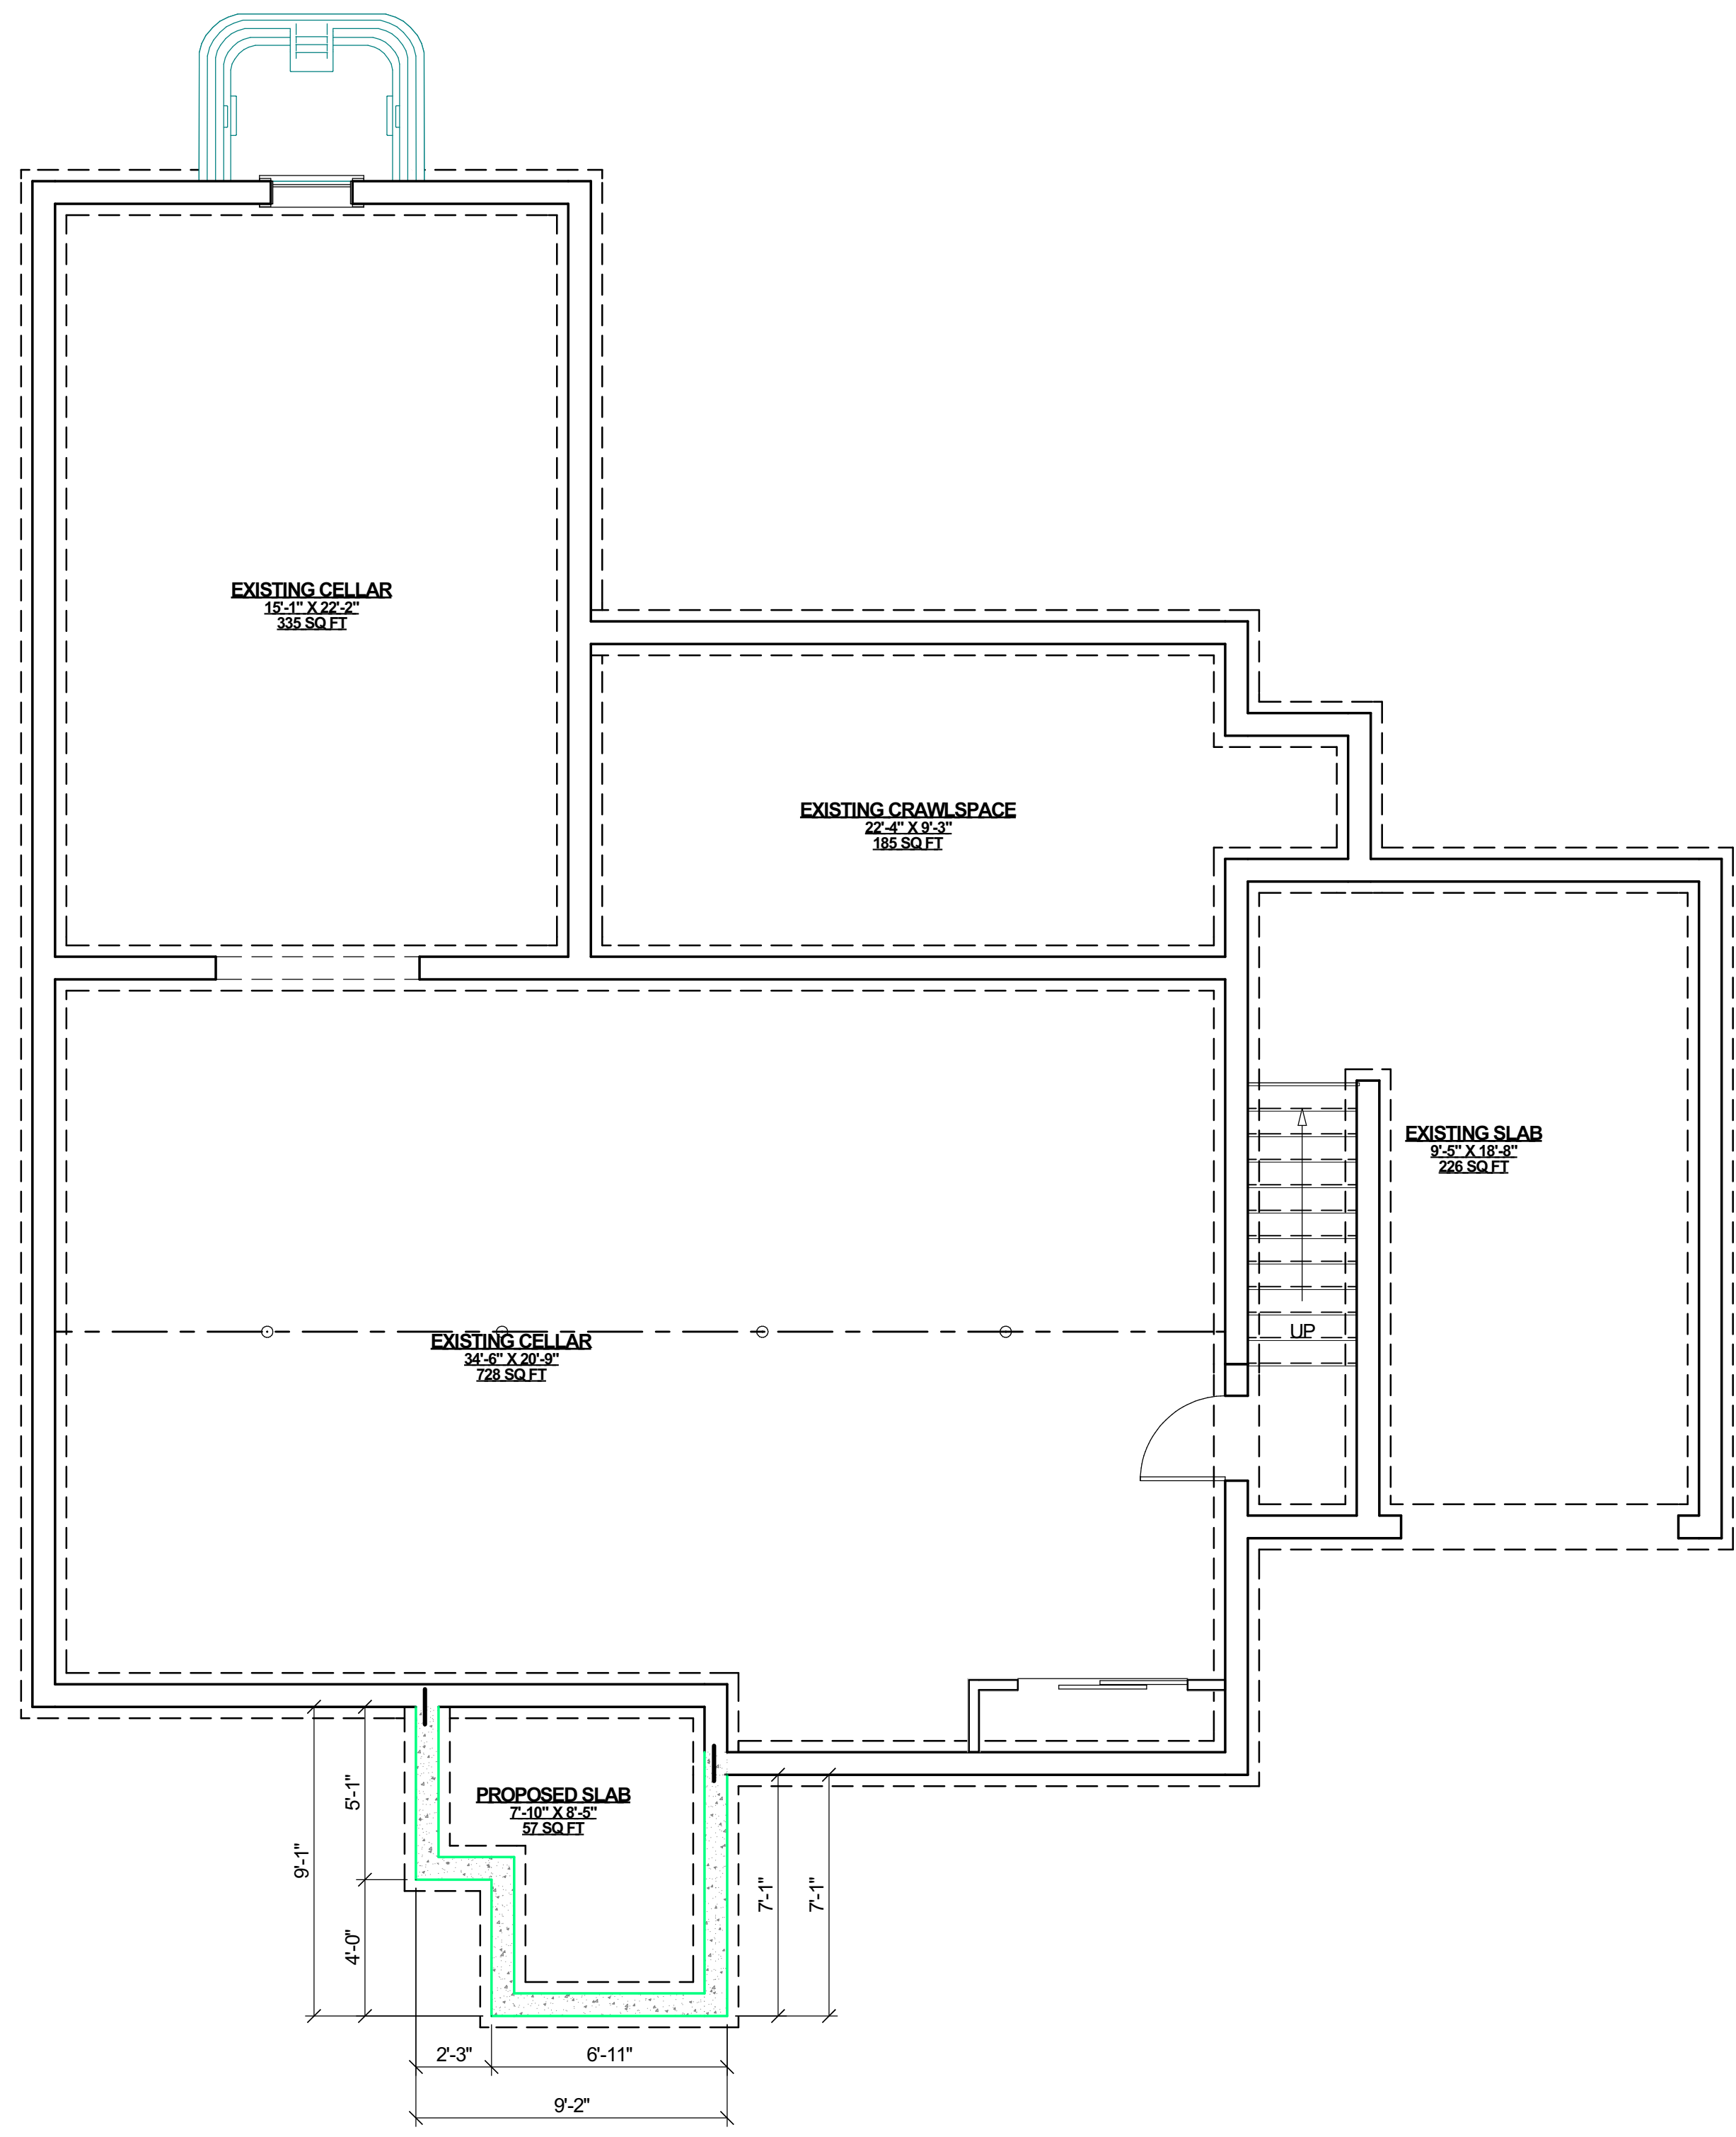

SHEET INDEX	
NO.	TITLE
A-1	DESIGN FLOOR PLANS
A-2	RENDERINGS
A-3	DESIGN ELEVATIONS
A-4	INTERIOR ELEVATIONS - PERSPECTIVES - RENDERINGS
A-5	
A-6	CODE SHEET
A-7	SPECIFICATIONS
A-8	LEGENDS & PLUMBING RISER DIAGRAMS
A-9	THERMAL PLANS
A-10	DEMOLITION PLANS
A-11	FOUNDATION PLAN
A-12	FIRST FLOOR CONSTRUCTION PLAN
A-13	ROOF PLAN
A-14	ELECTRICAL PLANS
A-15	ELEVATIONS
A-16	ELEVATION & SECTION
A-17	DETAILS
A-18	DETAILS
A-19	DETAILS
A-20	DETAILS
A-21	AIR SEAL DETAILS

NO.	DESCRIPTION	DATE
1	ISSUED FOR DESIGN REVIEW.	5-19-23

CAD File Name: \VALENTI DESIGN 1.layout

Architect's Seal

**EDWARD KOENIG ARCHITECT**

www.EDWARDKOENIG.COM

Architecture Firm:  
**EDWARD KOENIG - ARCHITECT**  
PO BOX 1051  
150 VETERANS MEMORIAL HWY.  
COMMACK, NY 11725  
631-948-7030 (cell & text)  
Website: www.EDWARDKOENIG.com  
Email: EDKOENIG49@gmail.com

Project Title:  
**ROOF RENOVATION**  
ANTHONY VALENTI  
8 ELLINGTON DRIVE  
EAST NORTH PORT, NY 11731  
516-524-9298  
DISTRICT 400 - SECTION 118 - BLOCK 2 - LOT 86

Sheet Title:  
**DESIGN FLOOR PLANS**

Drawing No.  
**A-1**



# ROOF RENOVATION

8 ELLINGTON DRIVE, EAST NORTH PORT, NY, 11731, 516-524-9298

Copyright of Architectural Drawings- These plans are protected by federal law and are subject to copyright protection as an "architectural work" under section 102 of the copyright act, 17 U.S.A. as amended December 1990 and known as Architectural Works Copyright Protection Act of 1990. These drawings are provided as an instrument for construction for the construction project at the address shown on the title block of the drawings and they may not be used for any project other than that listed at the address shown on the title block without the written consent and compensation of the architect. This protection includes but is not limited to the overall form as well as the arrangement and composition of spaces and elements of the designs. Under such protection, unauthorized use of these plans, work or home represented, can legally result in the cessation of construction or buildings being seized and/or monetary compensation to Edward Koenig.




SHEET INDEX	
NO.	TITLE
A-1	DESIGN FLOOR PLANS
A-2	RENDERINGS
A-3	DESIGN ELEVATIONS
A-4	INTERIOR ELEVATIONS - PERSPECTIVES - RENDERINGS
A-5	
A-6	CODE SHEET
A-7	SPECIFICATIONS
A-8	LEGENDS & PLUMBING RISER DIAGRAMS
A-9	THERMAL PLANS
A-10	DEMOLITION PLANS
A-11	FOUNDATION PLAN
A-12	FIRST FLOOR CONSTRUCTION PLAN
A-13	ROOF PLAN
A-14	ELECTRICAL PLANS
A-15	ELEVATIONS
A-16	ELEVATION & SECTION
A-17	DETAILS
A-18	DETAILS
A-19	DETAILS
A-20	DETAILS
A-21	AIR SEAL DETAILS

NO.	DESCRIPTION	DATE
1	ISSUED FOR DESIGN REVIEW.	5-19-23

CAD File Name: VALENTI DESIGN 1.layout

Architect's Seal

**EDWARD KOENIG  
ARCHITECT**

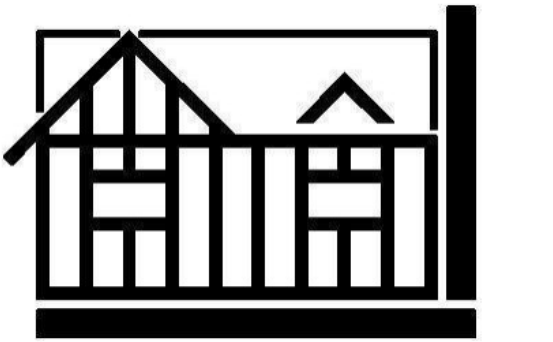

[www.EDWARDKOENIG.COM](http://www.EDWARDKOENIG.COM)

Architecture Firm:  
**EDWARD KOENIG - ARCHITECT**  
PO BOX 1051  
150 VETERANS MEMORIAL HWY.  
COMMACK, NY 11725  
631-948-7030 (cell & text)  
Website: [www.EDWARDKOENIG.com](http://www.EDWARDKOENIG.com)  
Email: [EDKOENIG49@gmail.com](mailto:EDKOENIG49@gmail.com)

Project Title:  
**ROOF RENOVATION**  
ANTHONY VALENTI  
8 ELLINGTON DRIVE  
EAST NORTH PORT, NY 11731  
516-524-9298  
DISTRICT 400 - SECTION 118 - BLOCK 2 - LOT 86

Sheet Title  
**RENDERINGS**

Drawing No.  
**A-2**



# ROOF RENOVATION

8 ELLINGTON DRIVE, EAST NORTH PORT, NY, 11731, 516-524-9298

Copyright of Architectural Drawings- These plans are protected by federal law and are subject to copyright protection as an "architectural work" under section 102 of the copyright act, 17 U.S.A. as amended December 1990 and known as Architectural Works Copyright Protection Act of 1990. These drawings are provided as an instrument for construction for the construction project at the address shown on the title block of the drawings and they may not be used for any project other than that listed at the address shown on the title block without the written consent and compensation of the architect. This protection includes but is not limited to the overall form as well as the arrangement and composition of spaces and elements of the designs. Under such protection, unauthorized use of these plans, work or home represented, can legally result in the cessation of construction or buildings being seized and/or monetary compensation to Edward Koenig.

## SHEET INDEX


NO.	TITLE
A-1	DESIGN FLOOR PLANS
A-2	RENDERINGS
A-3	DESIGN ELEVATIONS
A-4	INTERIOR ELEVATIONS - PERSPECTIVES - RENDERINGS
A-5	RENDERINGS
A-6	CODE SHEET
A-7	SPECIFICATIONS
A-8	LEGENDS & PLUMBING RISER DIAGRAMS
A-9	THERMAL PLANS
A-10	DEMOLITION PLANS
A-11	FOUNDATION PLAN
A-12	FIRST FLOOR CONSTRUCTION PLAN
A-13	ROOF PLAN
A-14	ELECTRICAL PLANS
A-15	ELEVATIONS
A-16	ELEVATION & SECTION
A-17	DETAILS
A-18	DETAILS
A-19	DETAILS
A-20	DETAILS
A-21	AIR SEAL DETAILS

NO.	DESCRIPTION	DATE
1	ISSUED FOR DESIGN REVIEW.	5-19-23

CAD File Name: VALENTI DESIGN 1.layout

Architect's Seal

**EDWARD KOENIG  
ARCHITECT**

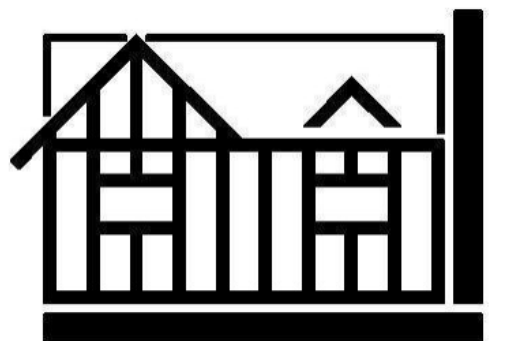

[www.EDWARDKOENIG.COM](http://www.EDWARDKOENIG.COM)

Architecture Firm:  
**EDWARD KOENIG - ARCHITECT**

PO BOX 1051  
150 VETERANS MEMORIAL HWY.  
COMMACK, NY 11725  
631-948-7030 (cell & text)  
Website: [www.EDWARDKOENIG.com](http://www.EDWARDKOENIG.com)  
Email: [EDKOENIG49@gmail.com](mailto:EDKOENIG49@gmail.com)

Project Title:

**ROOF RENOVATION**  
ANTHONY VALENTI  
8 ELLINGTON DRIVE  
EAST NORTH PORT, NY 11731  
516-524-9298


DISTRICT 400 - SECTION 118 - BLOCK 2 - LOT 86

Sheet Title


**DESIGN ELEVATIONS**

Drawing No.


**A-3**

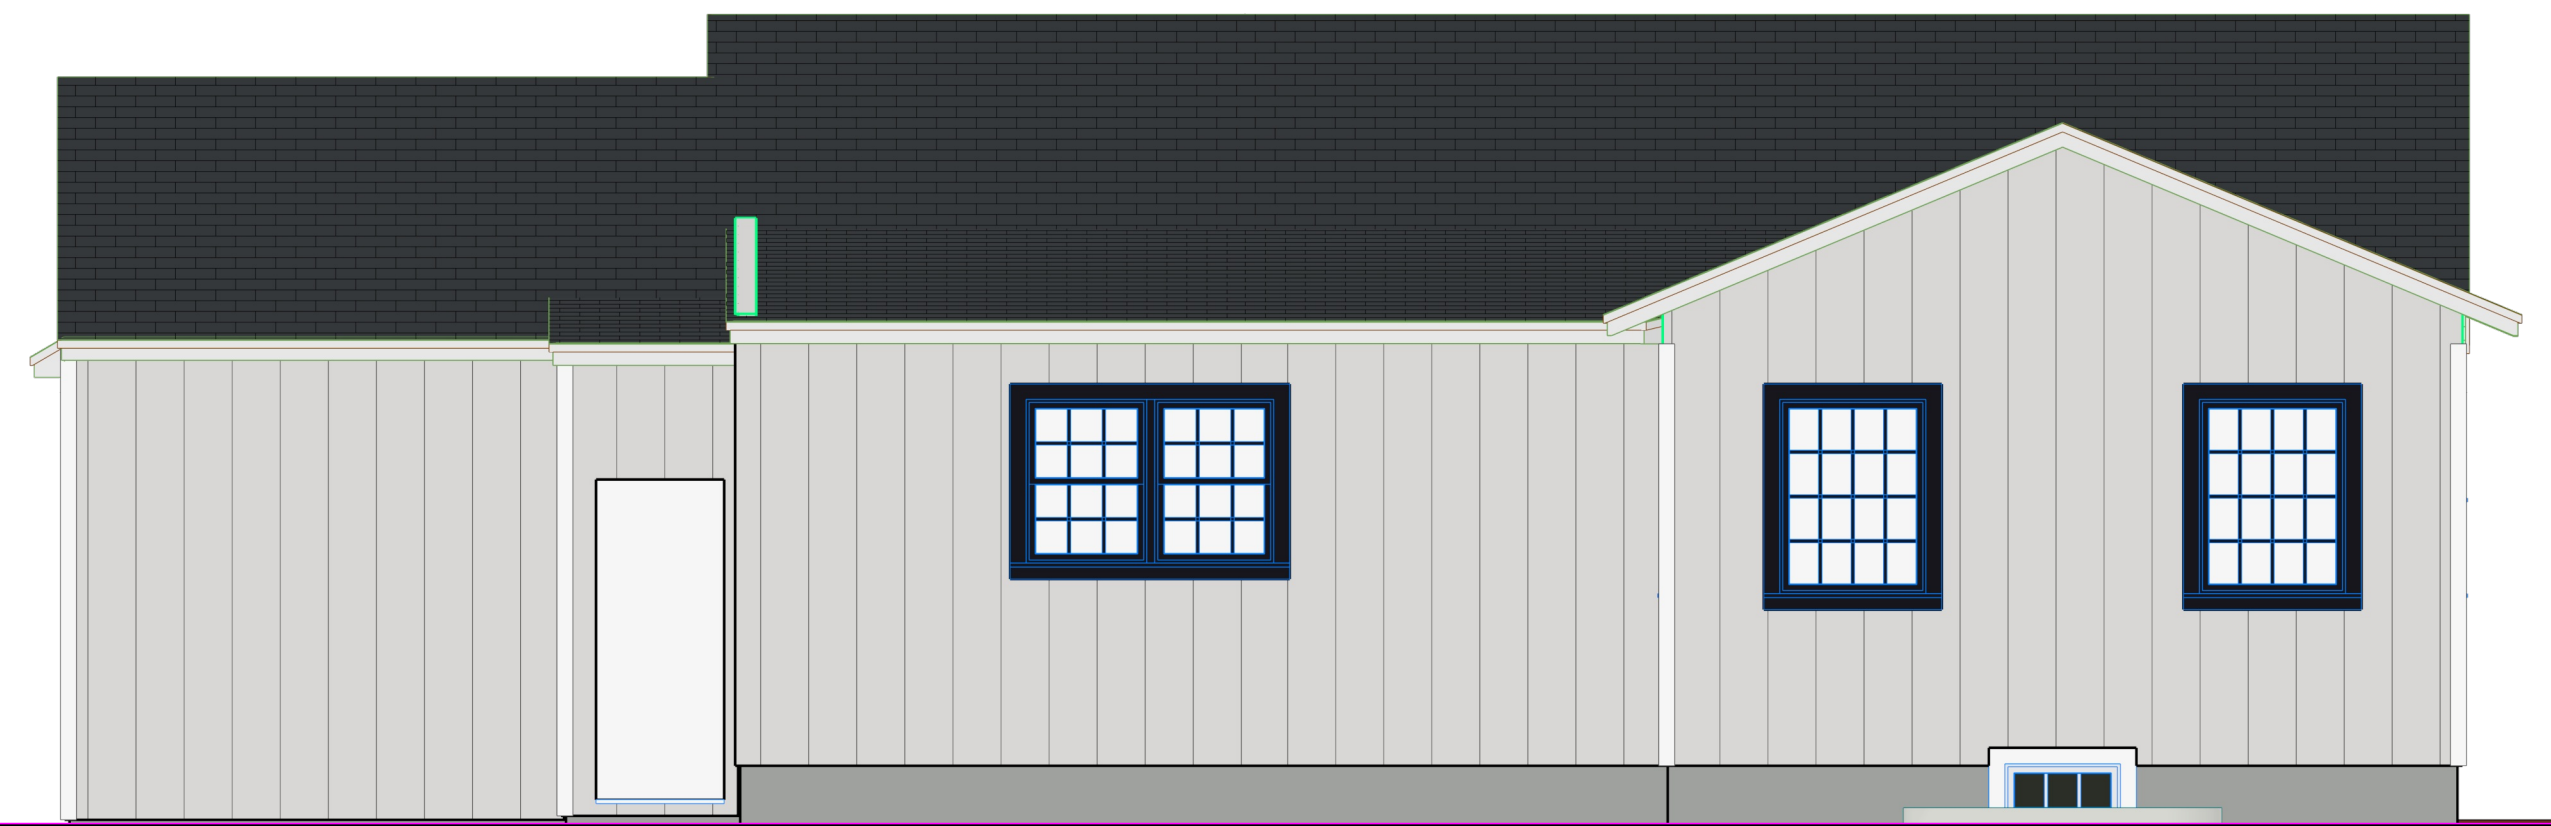


**REAR DESIGN ELEVATION**  
SCALE: 1/4" = 1'-0"

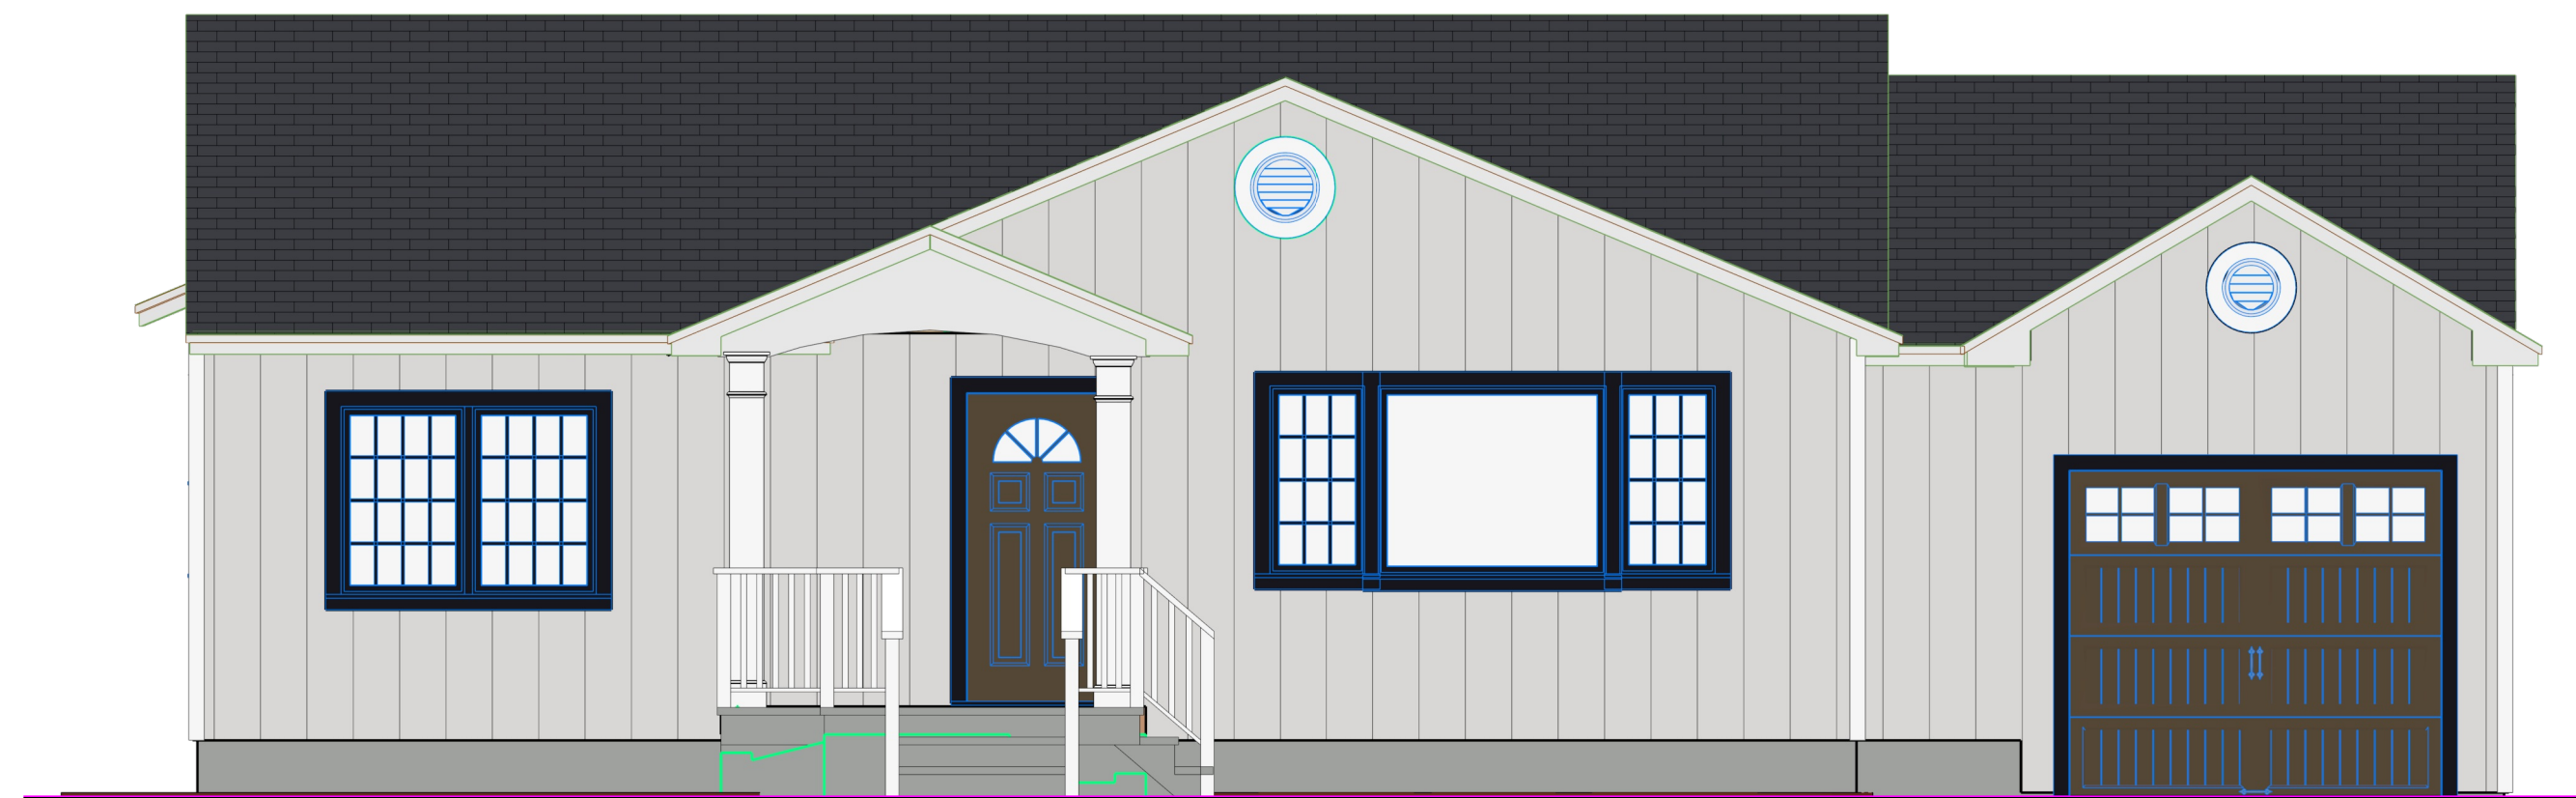

**FRONT DESIGN ELEVATION**  
SCALE: 1/4" = 1'-0"

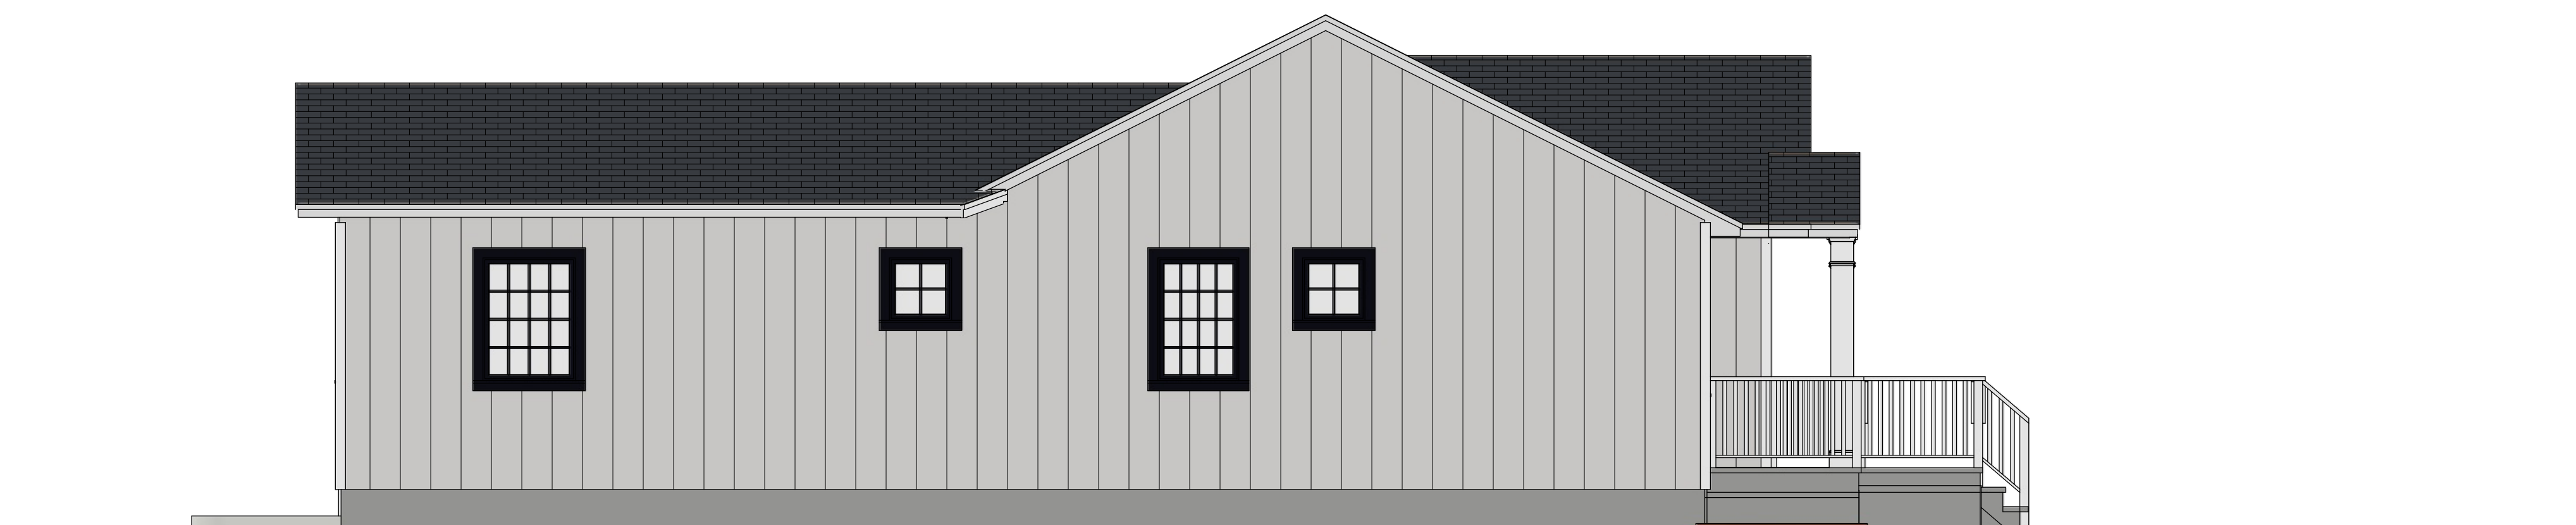

**LEFT DESIGN ELEVATION**  
SCALE: 1/4" = 1'-0"

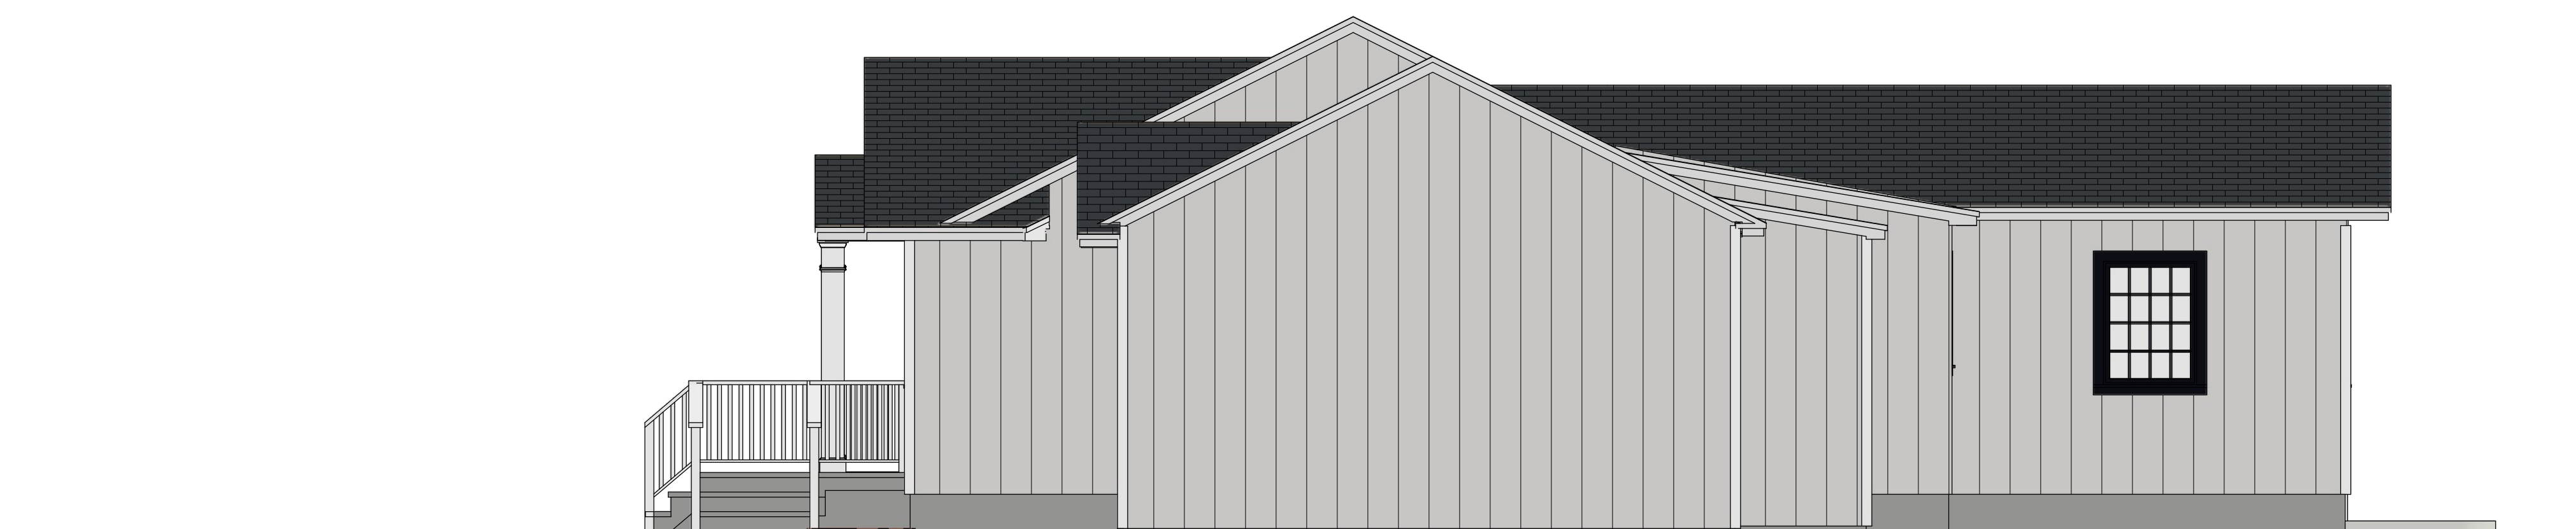

**RIGHT DESIGN ELEVATION**  
SCALE: 1/4" = 1'-0"